



Archived Content

Information identified as archived is provided for reference, research or recordkeeping purposes. It is not subject to the Government of Canada Web Standards and has not been altered or updated since it was archived. Some of this archived content is available only in one official language. Translation by CMHC can be requested and will be provided if demand is sufficient.

Contenu archivé

Le contenu identifié comme archivé est fourni à des fins de référence, de recherche ou de tenue des dossiers; il n'est pas assujetti aux normes Web du gouvernement du Canada. Aucune modification ou mise à jour n'y a été apportée depuis son archivage. Une partie du contenu archivé n'existe que dans une seule des langues officielles. La SCHL en fera la traduction dans l'autre langue officielle si la demande est suffisante.

COMPETITION SERIES

Project #: 299 Both Number of Sheets: 4
Architect: Earl R. Dunlop, Ontario
1958

Number of Storeys: 1, Bungalow--carport attached
Single detached

Number of Bedrooms: 3

Fireplace? no,

Basement: -Yes--unfinished
-Laundry tubs located

Cladding:

Primary: Brick

-

Secondary: Plywood panelling
-3/8" firplywood accent panels

Other: N/A

Roof:

Materials: Tar and gravel,

Shape: Flat/gabled--shallow rise

Special Features: N/A

-

N/A


-

N/A

-


N/A

-

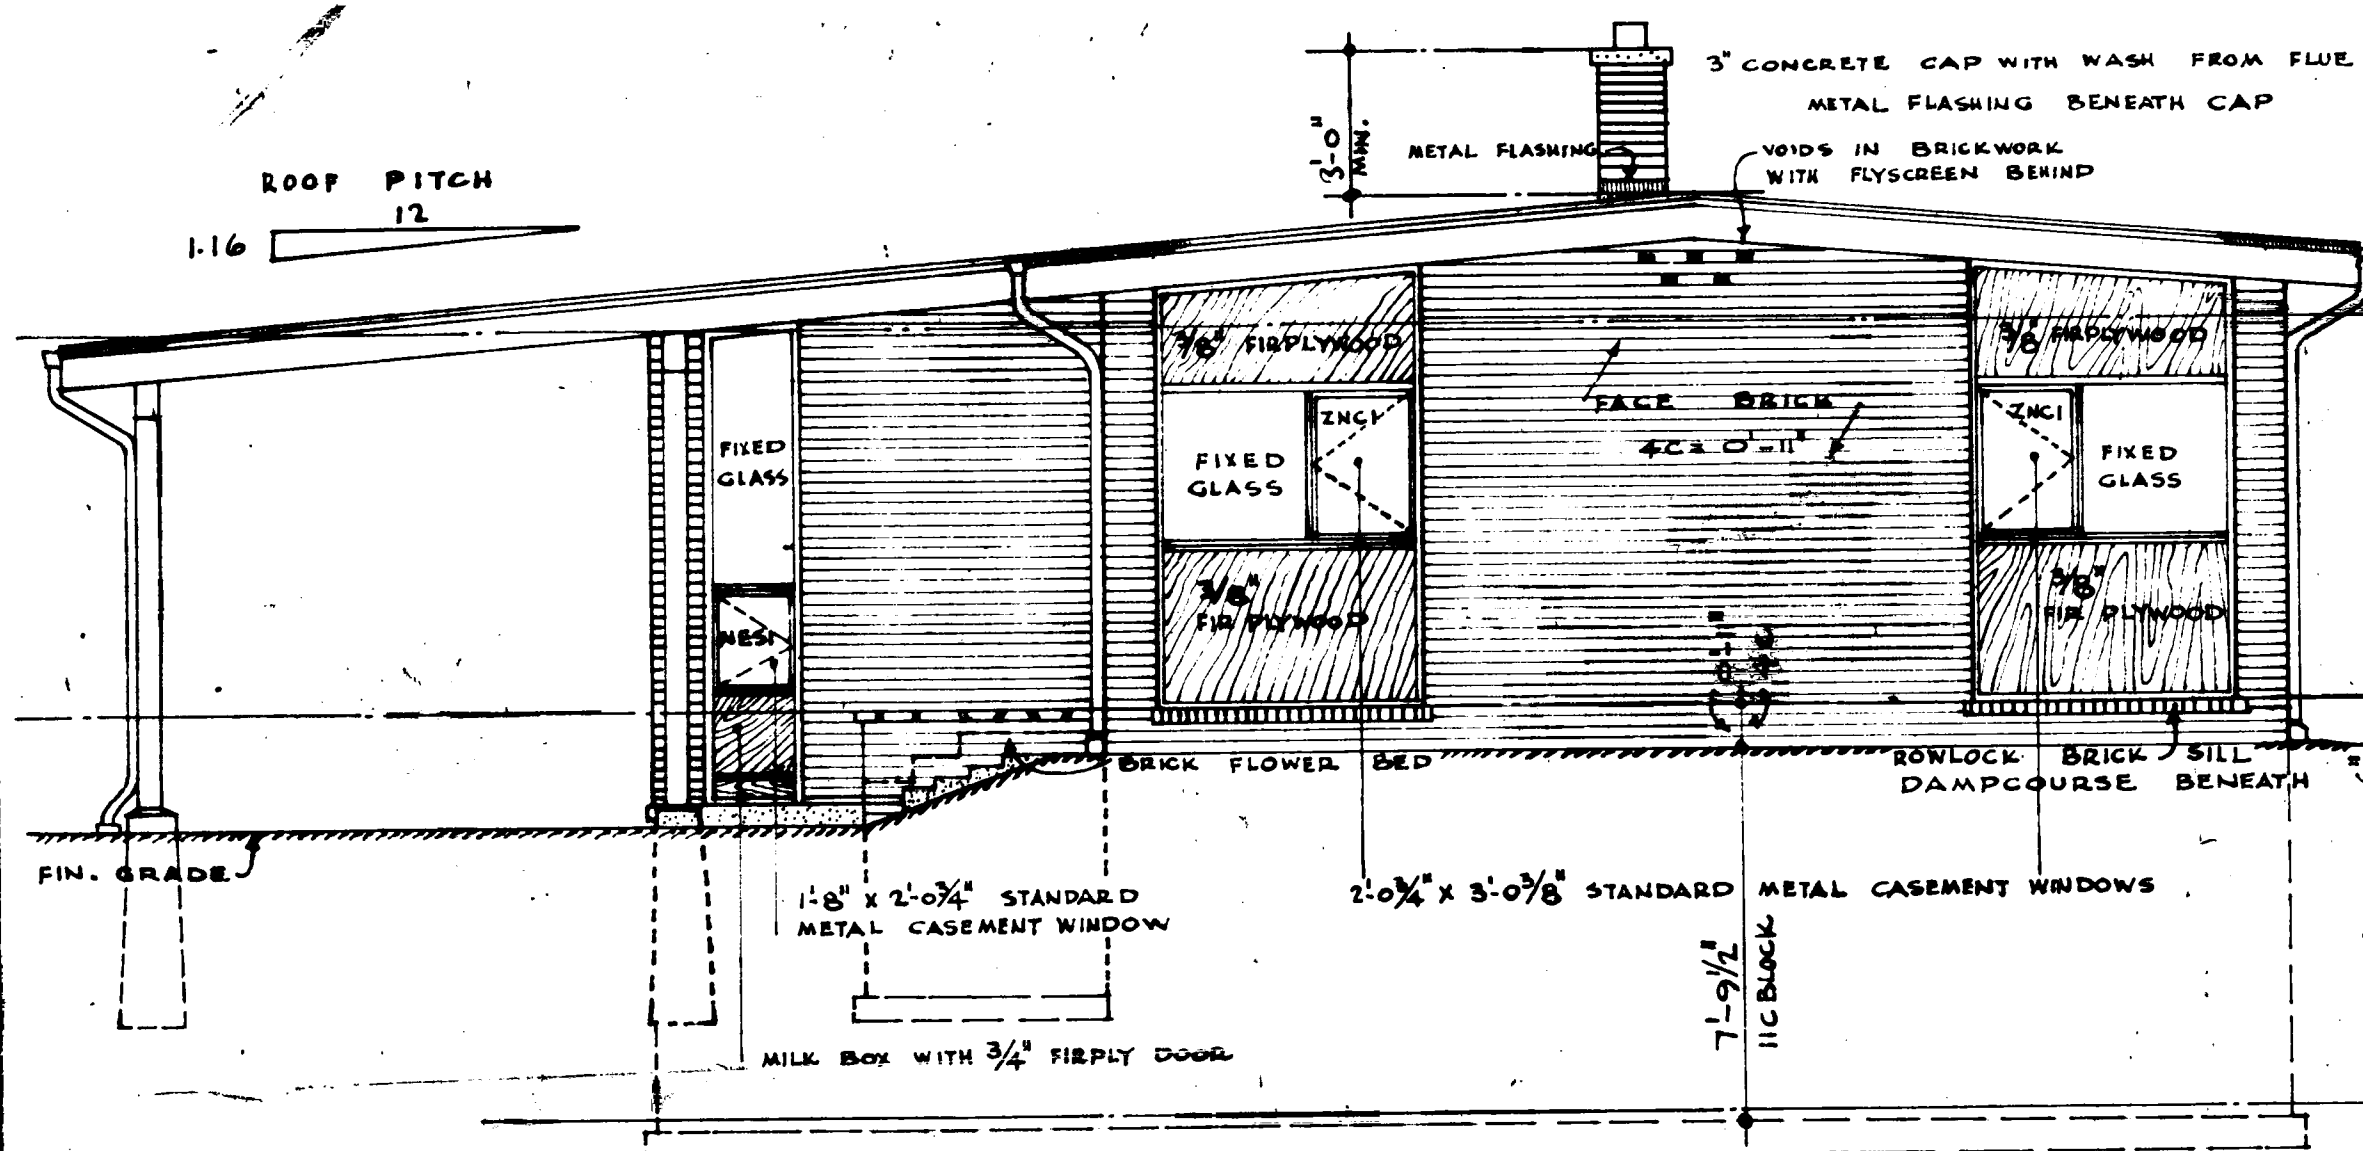


FRONT ELEVATION

SCALE: 1/4" = 1'-0"

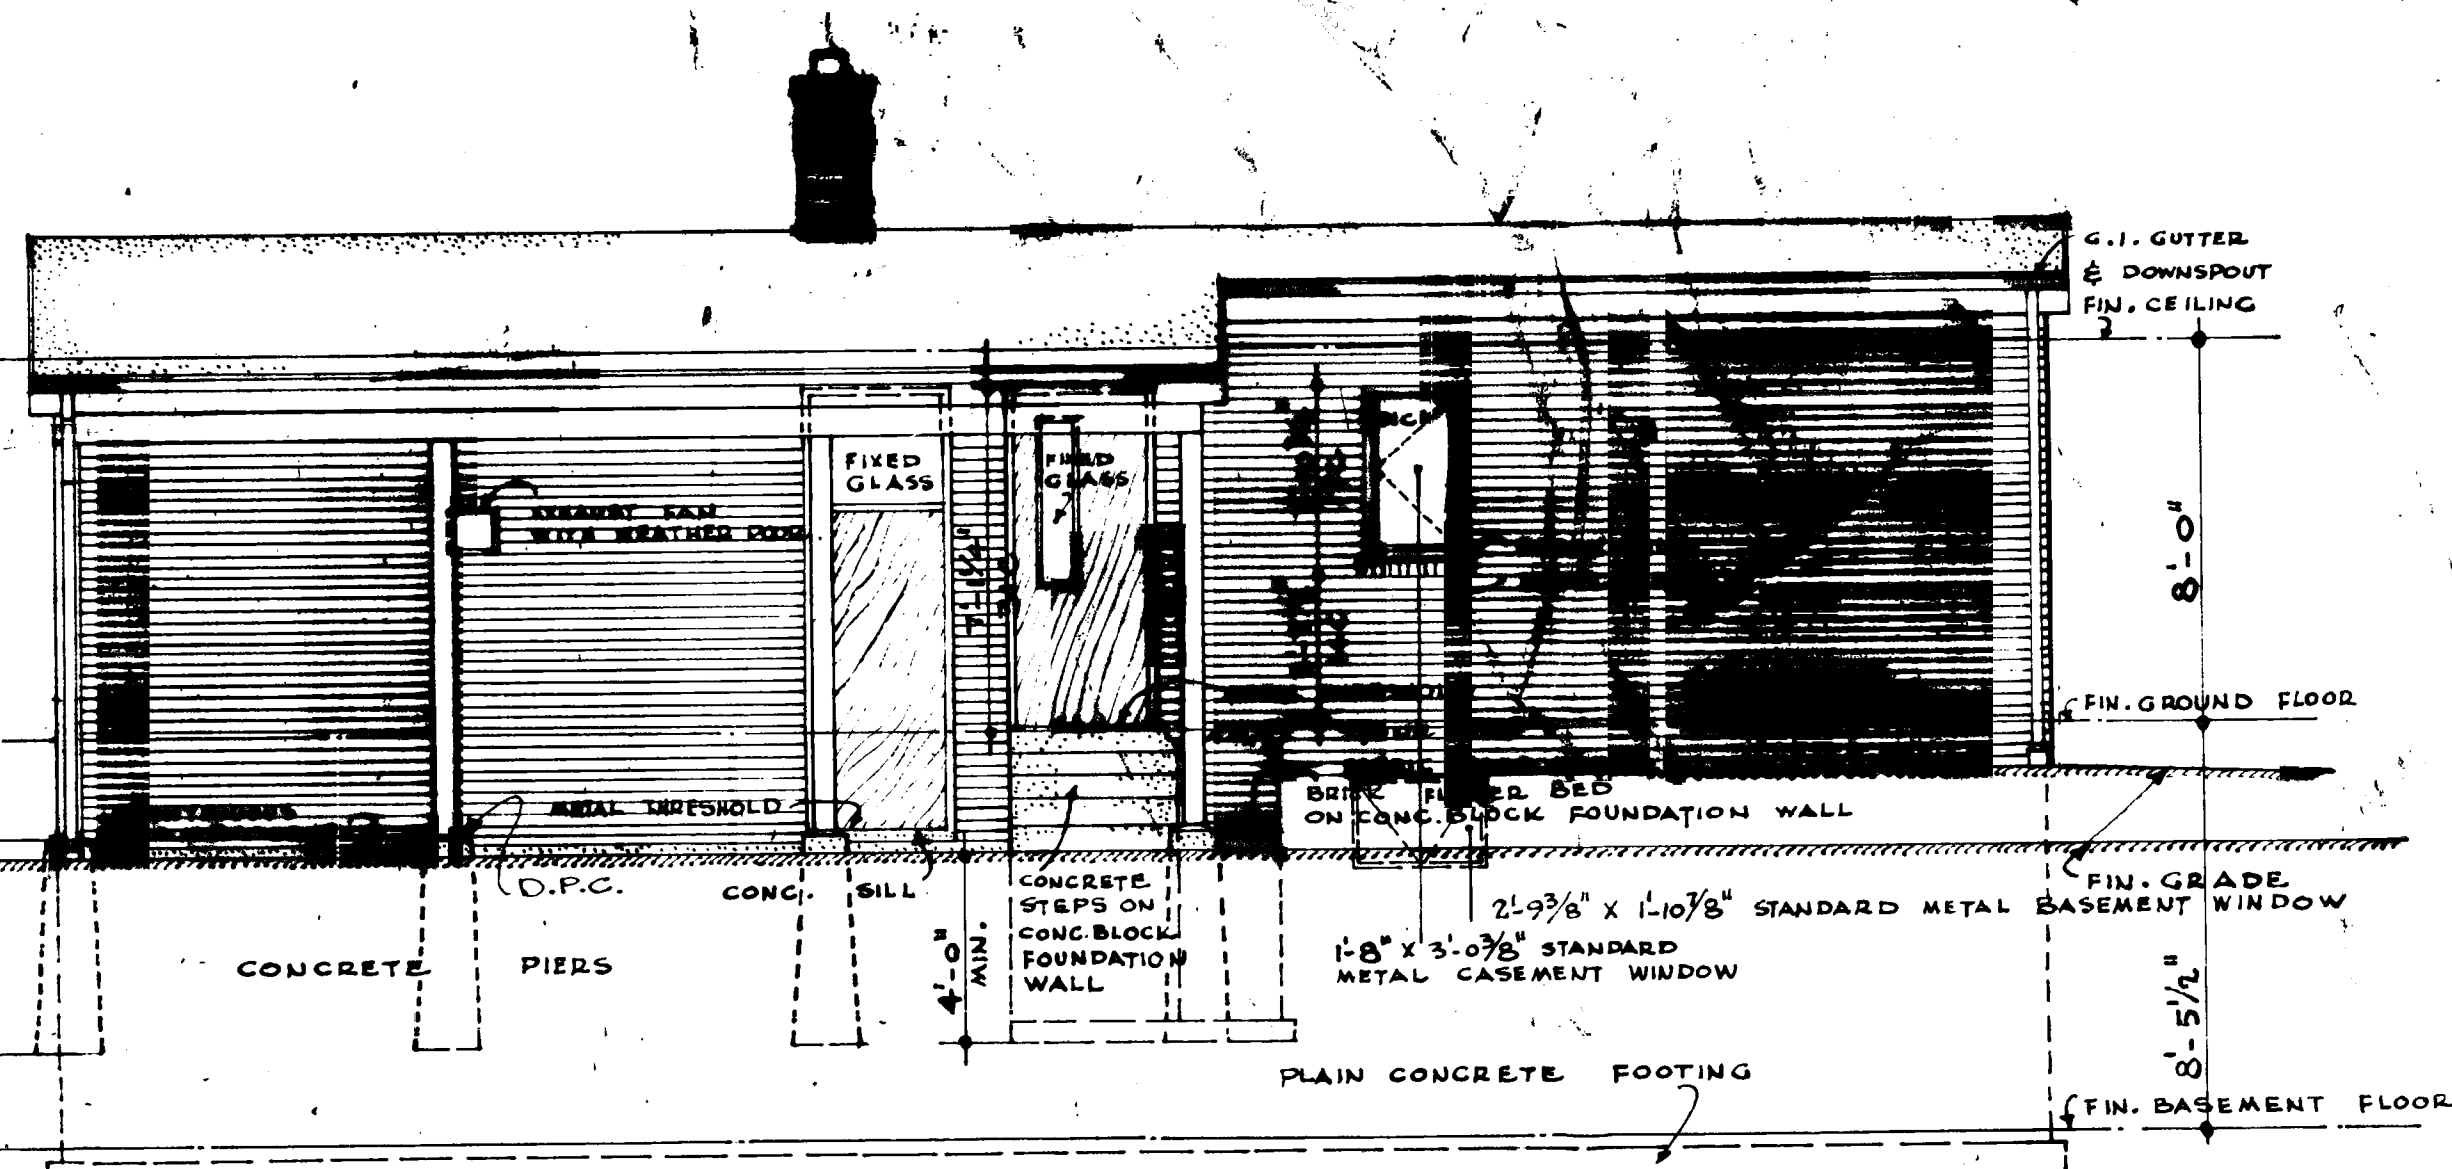


LEFT SIDE ELEVATION

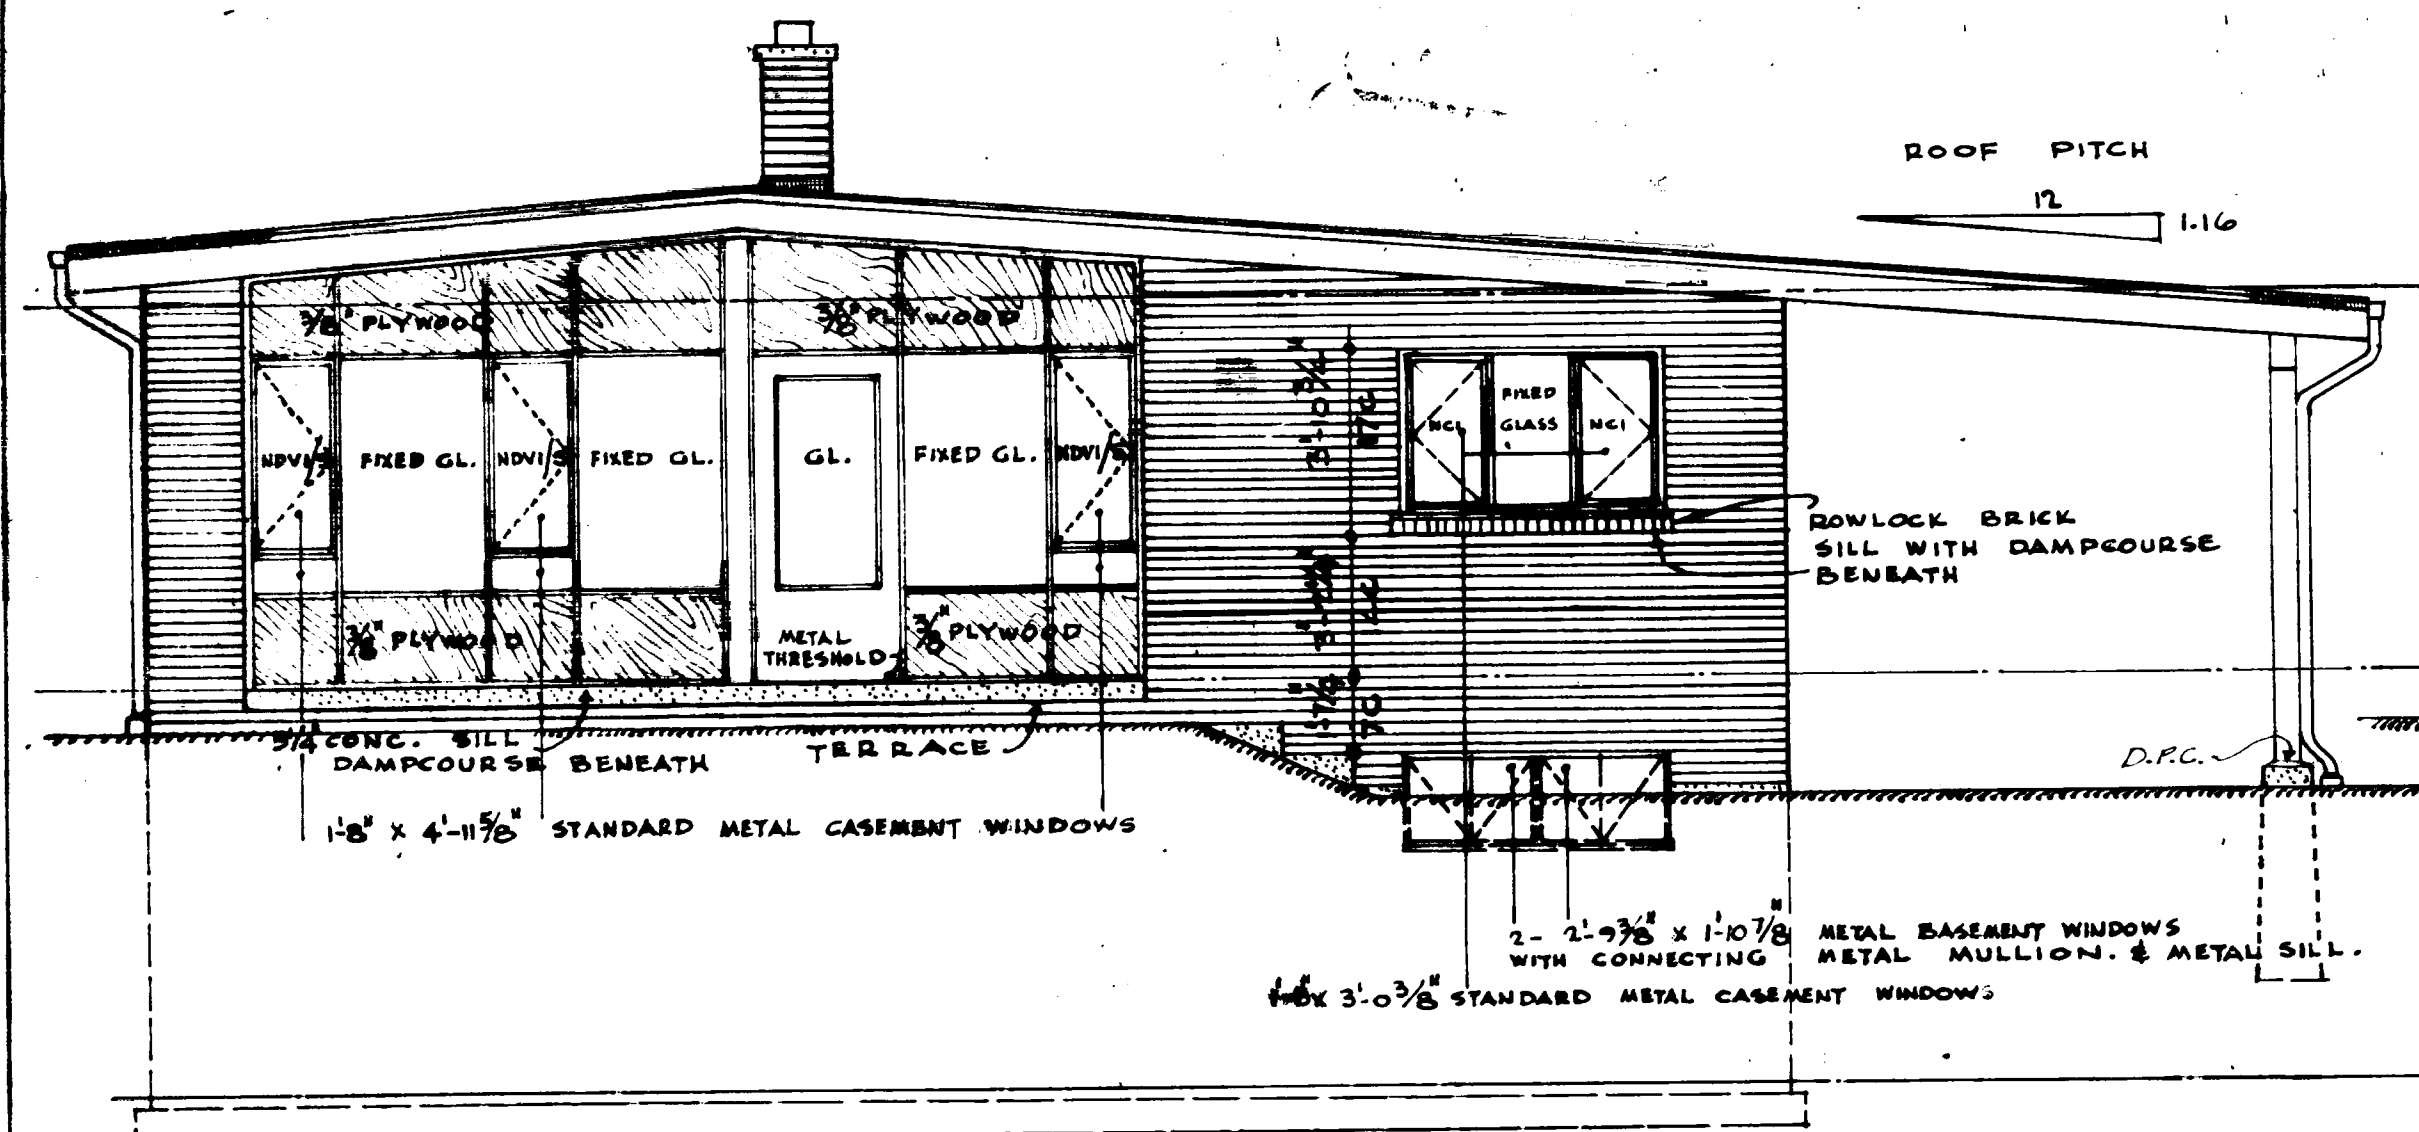


BACK ELEVATION

SCALE: 1/4" = 1'-0"

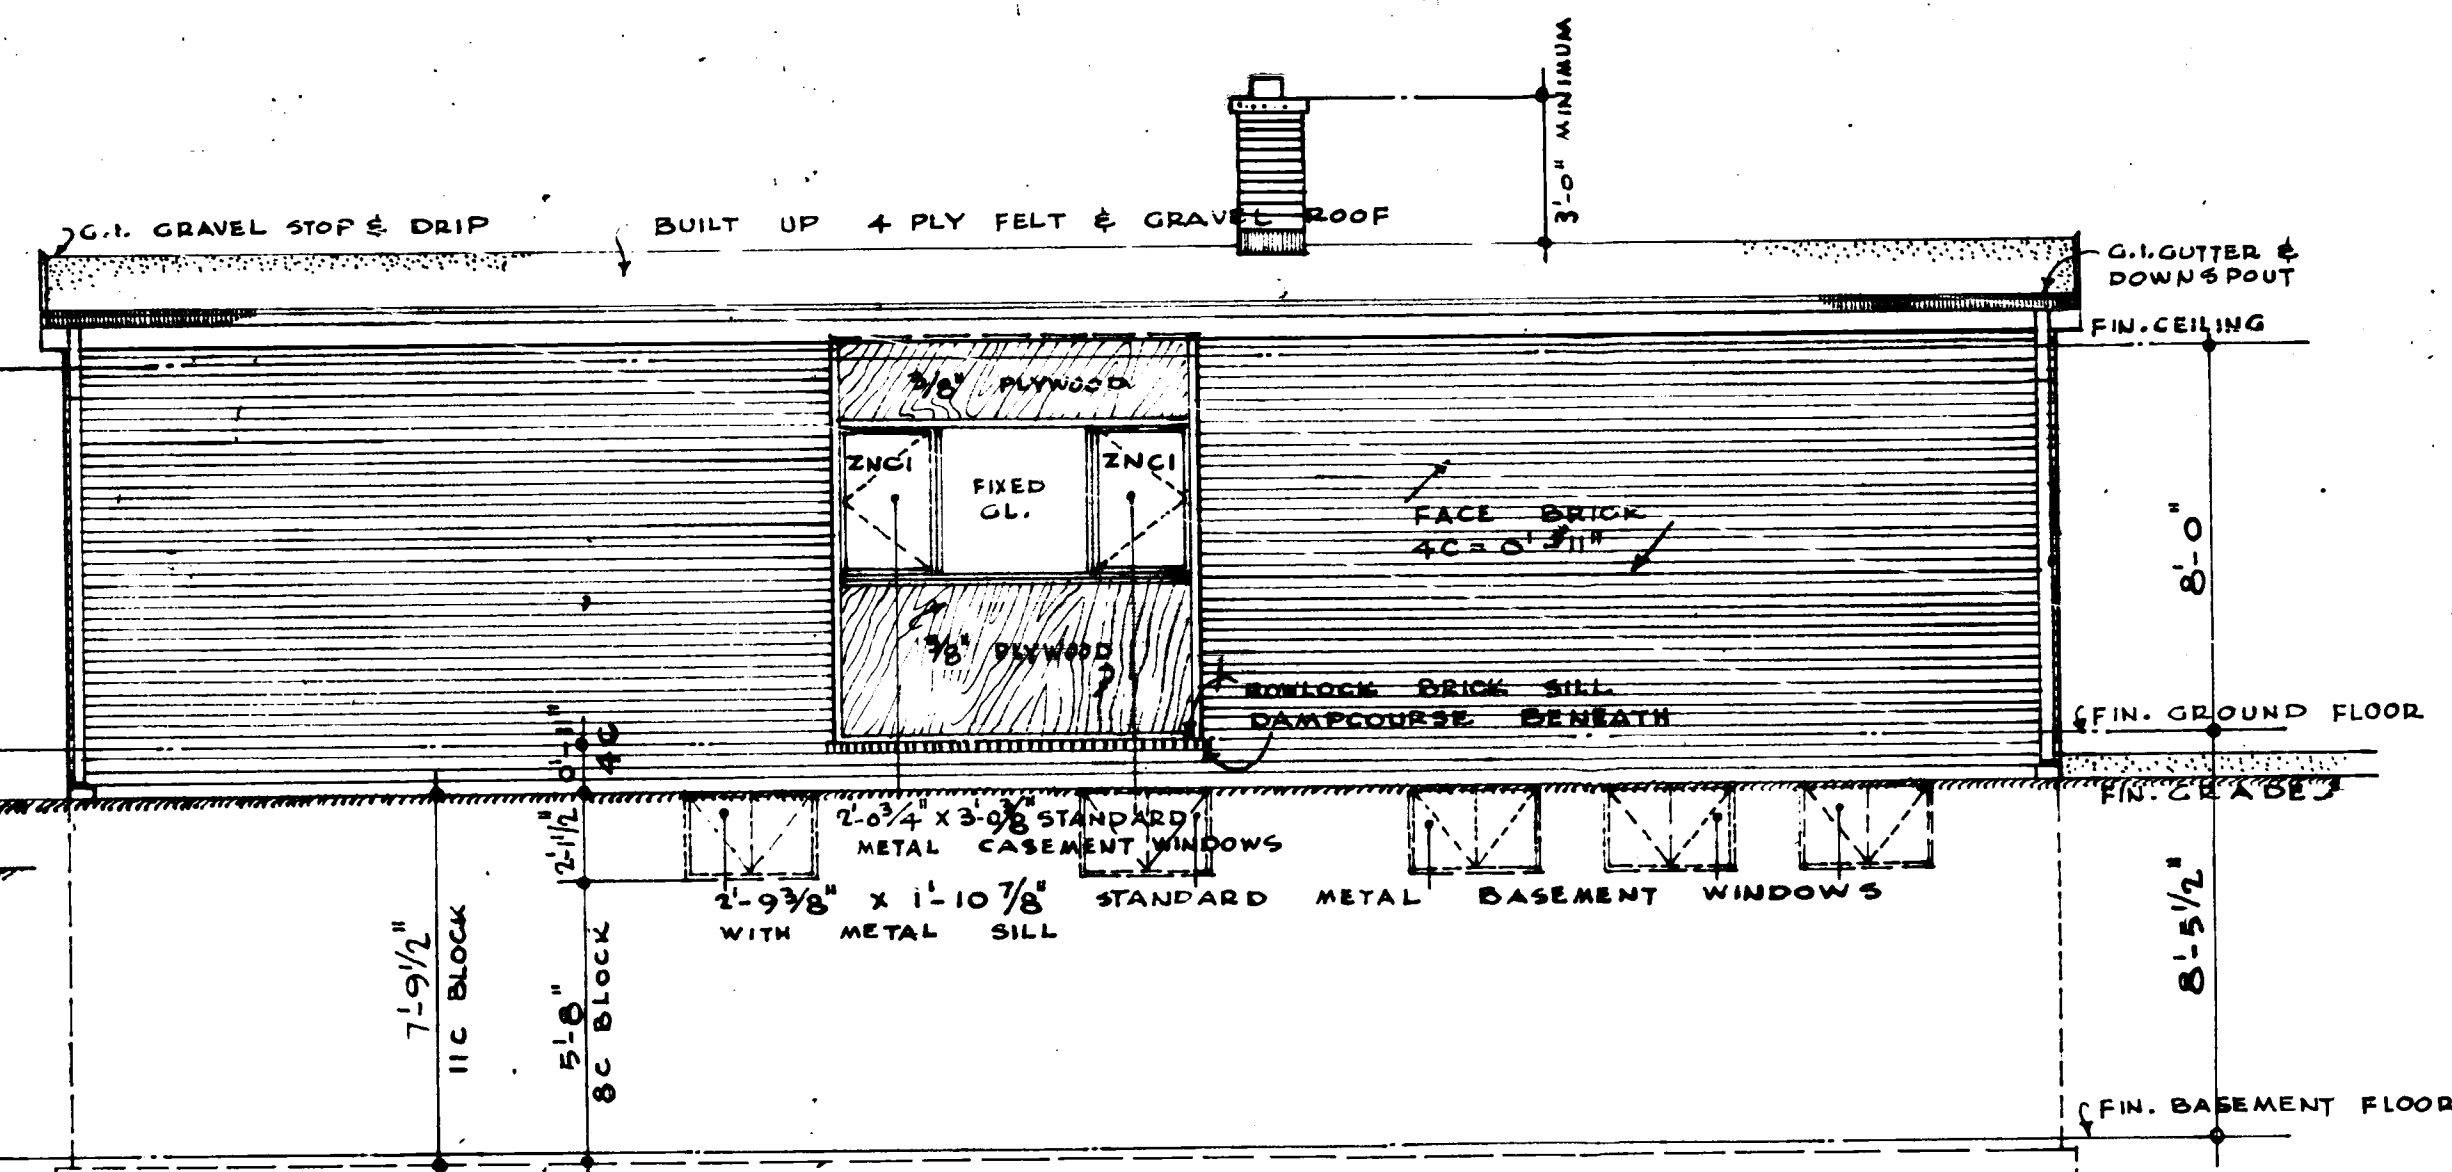


RIGHT SIDE ELEVATION

3/14/58 V. Kozel		272-68 GENERAL 7	
DATE	NHA STDS	CHKD BY	DATE REVISIONS BY
ARCHITECT		ARCHITECT	
EARL R. DUNLOP		EARL R. DUNLOP	
MEMBER		DATE 4 DEC. 1958	
ARCHITECT		DESIGN NO SHEET NO	
		299 2 of 4	
CENTRAL MORTGAGE AND HOUSING CORPORATION			

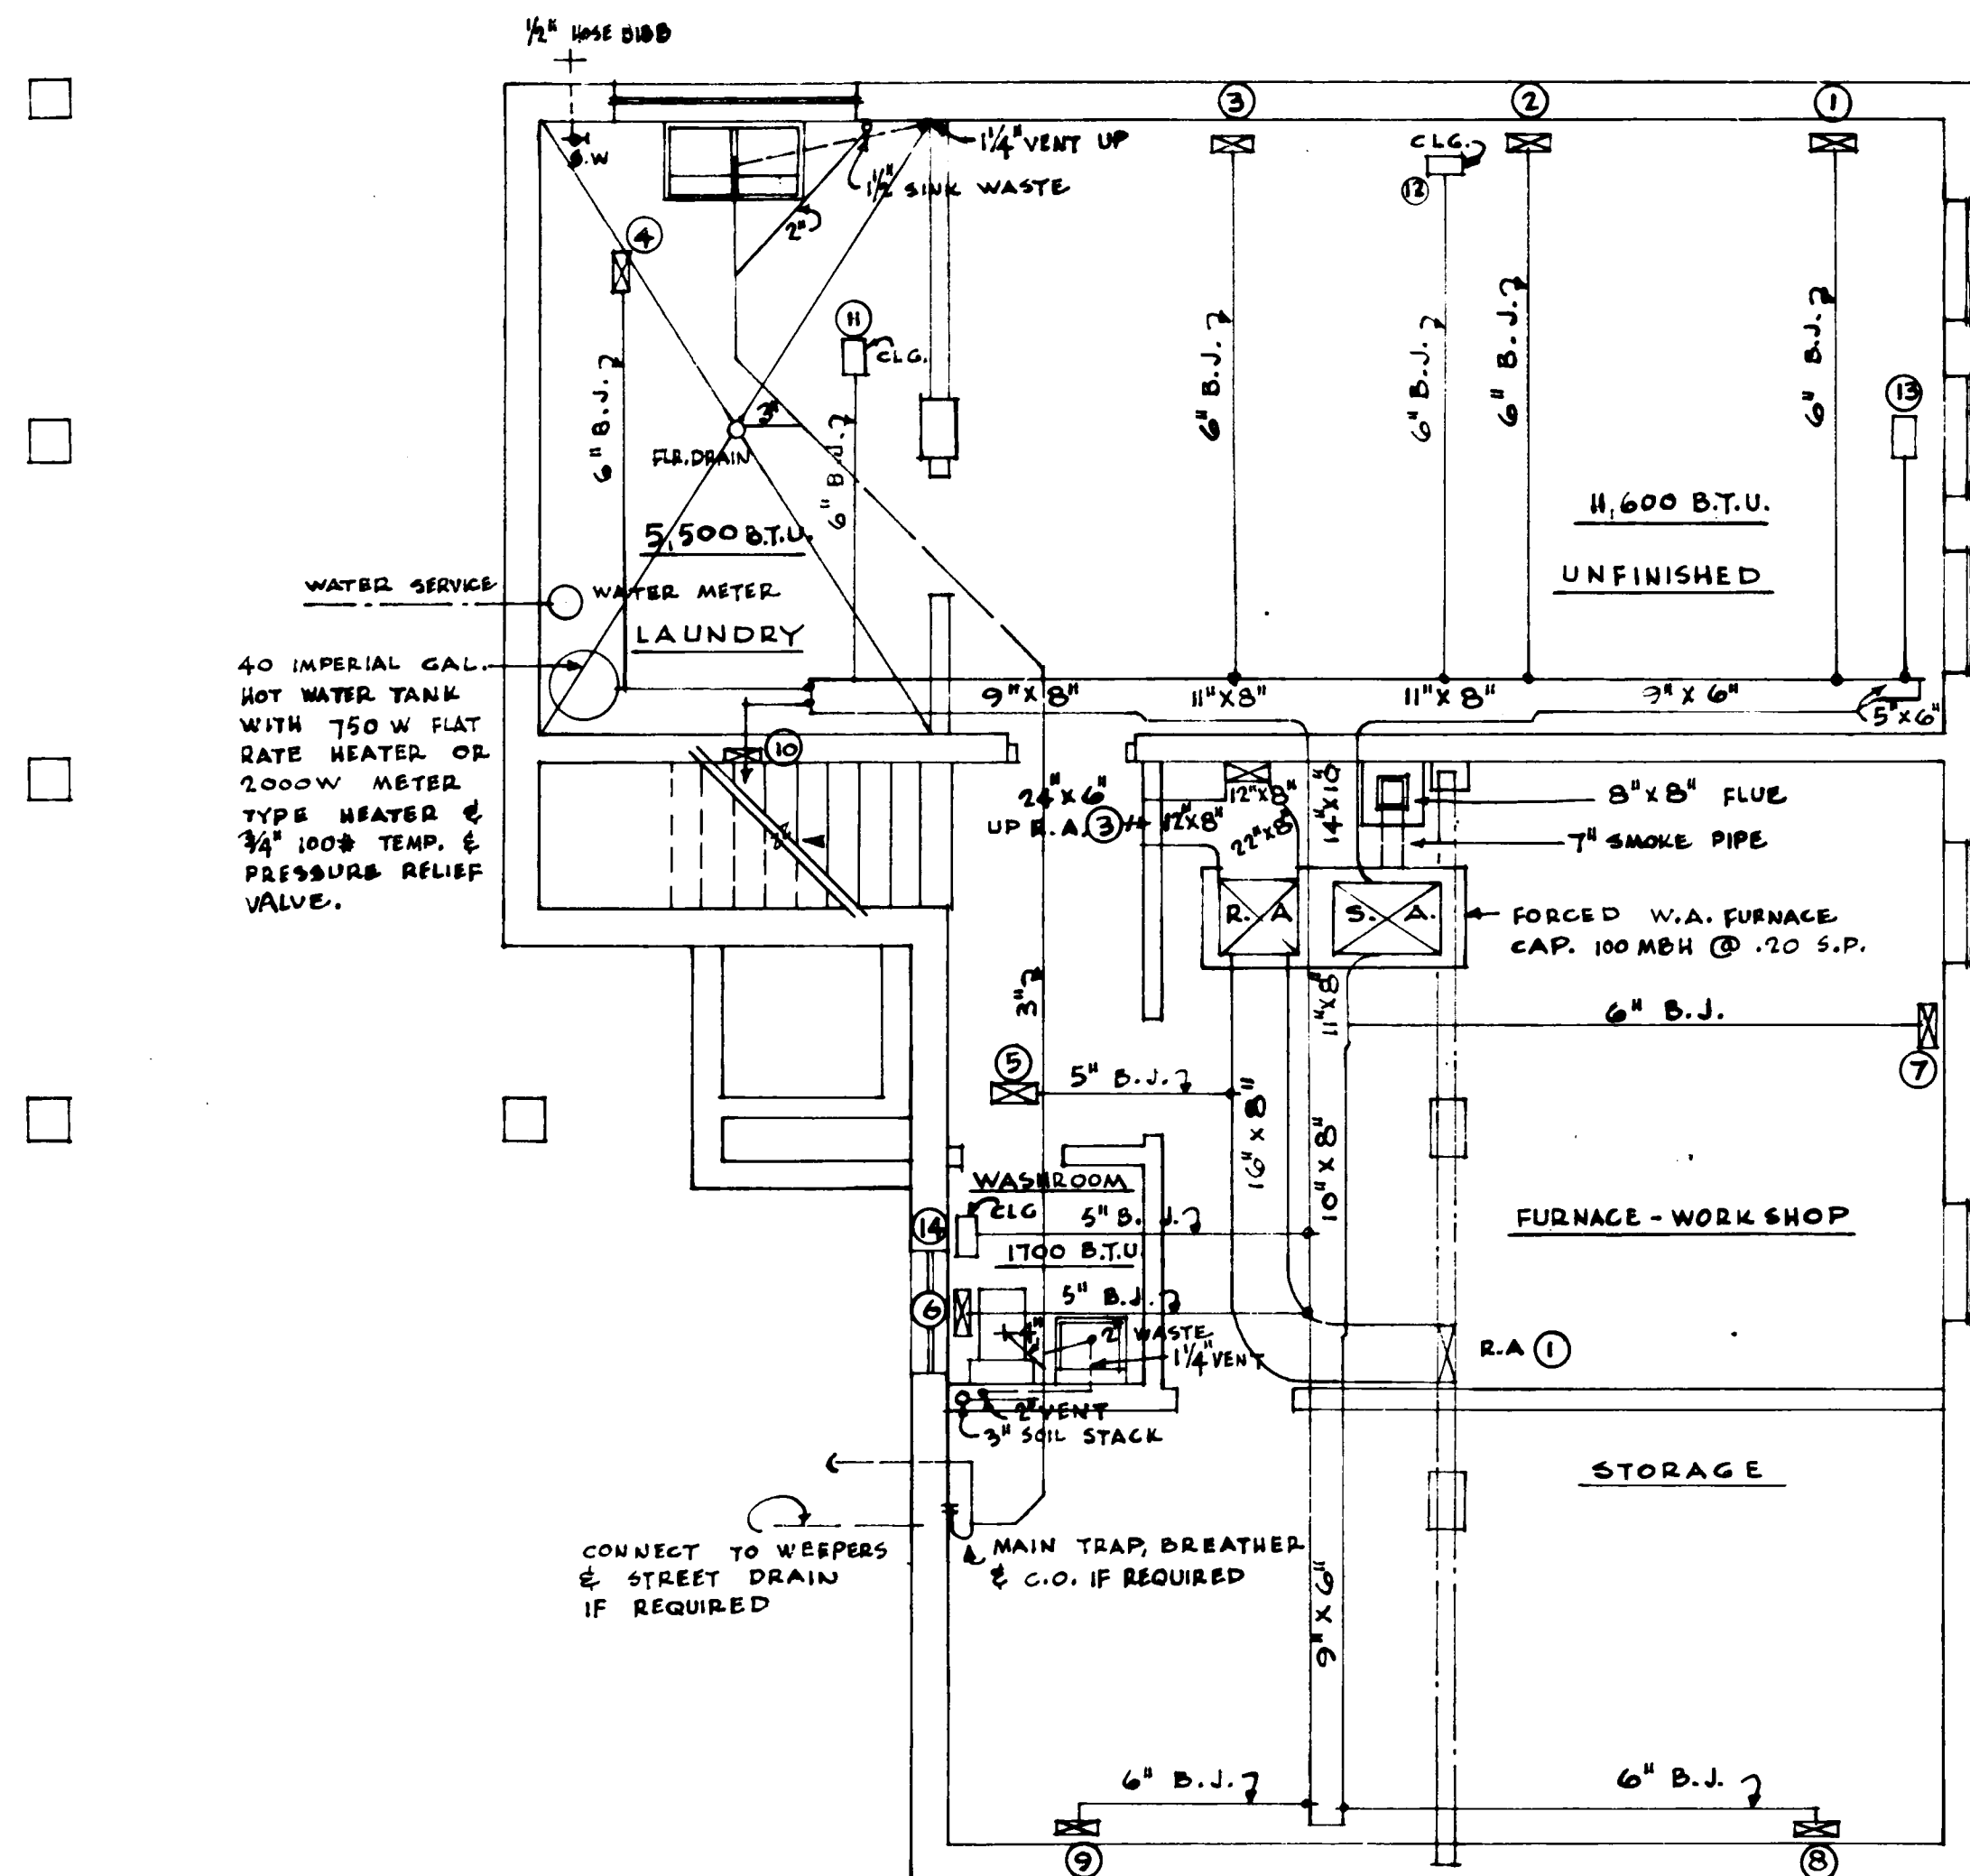

BASEMENT FLOOR PLAN SCALE: 1/4" = 1'-0"

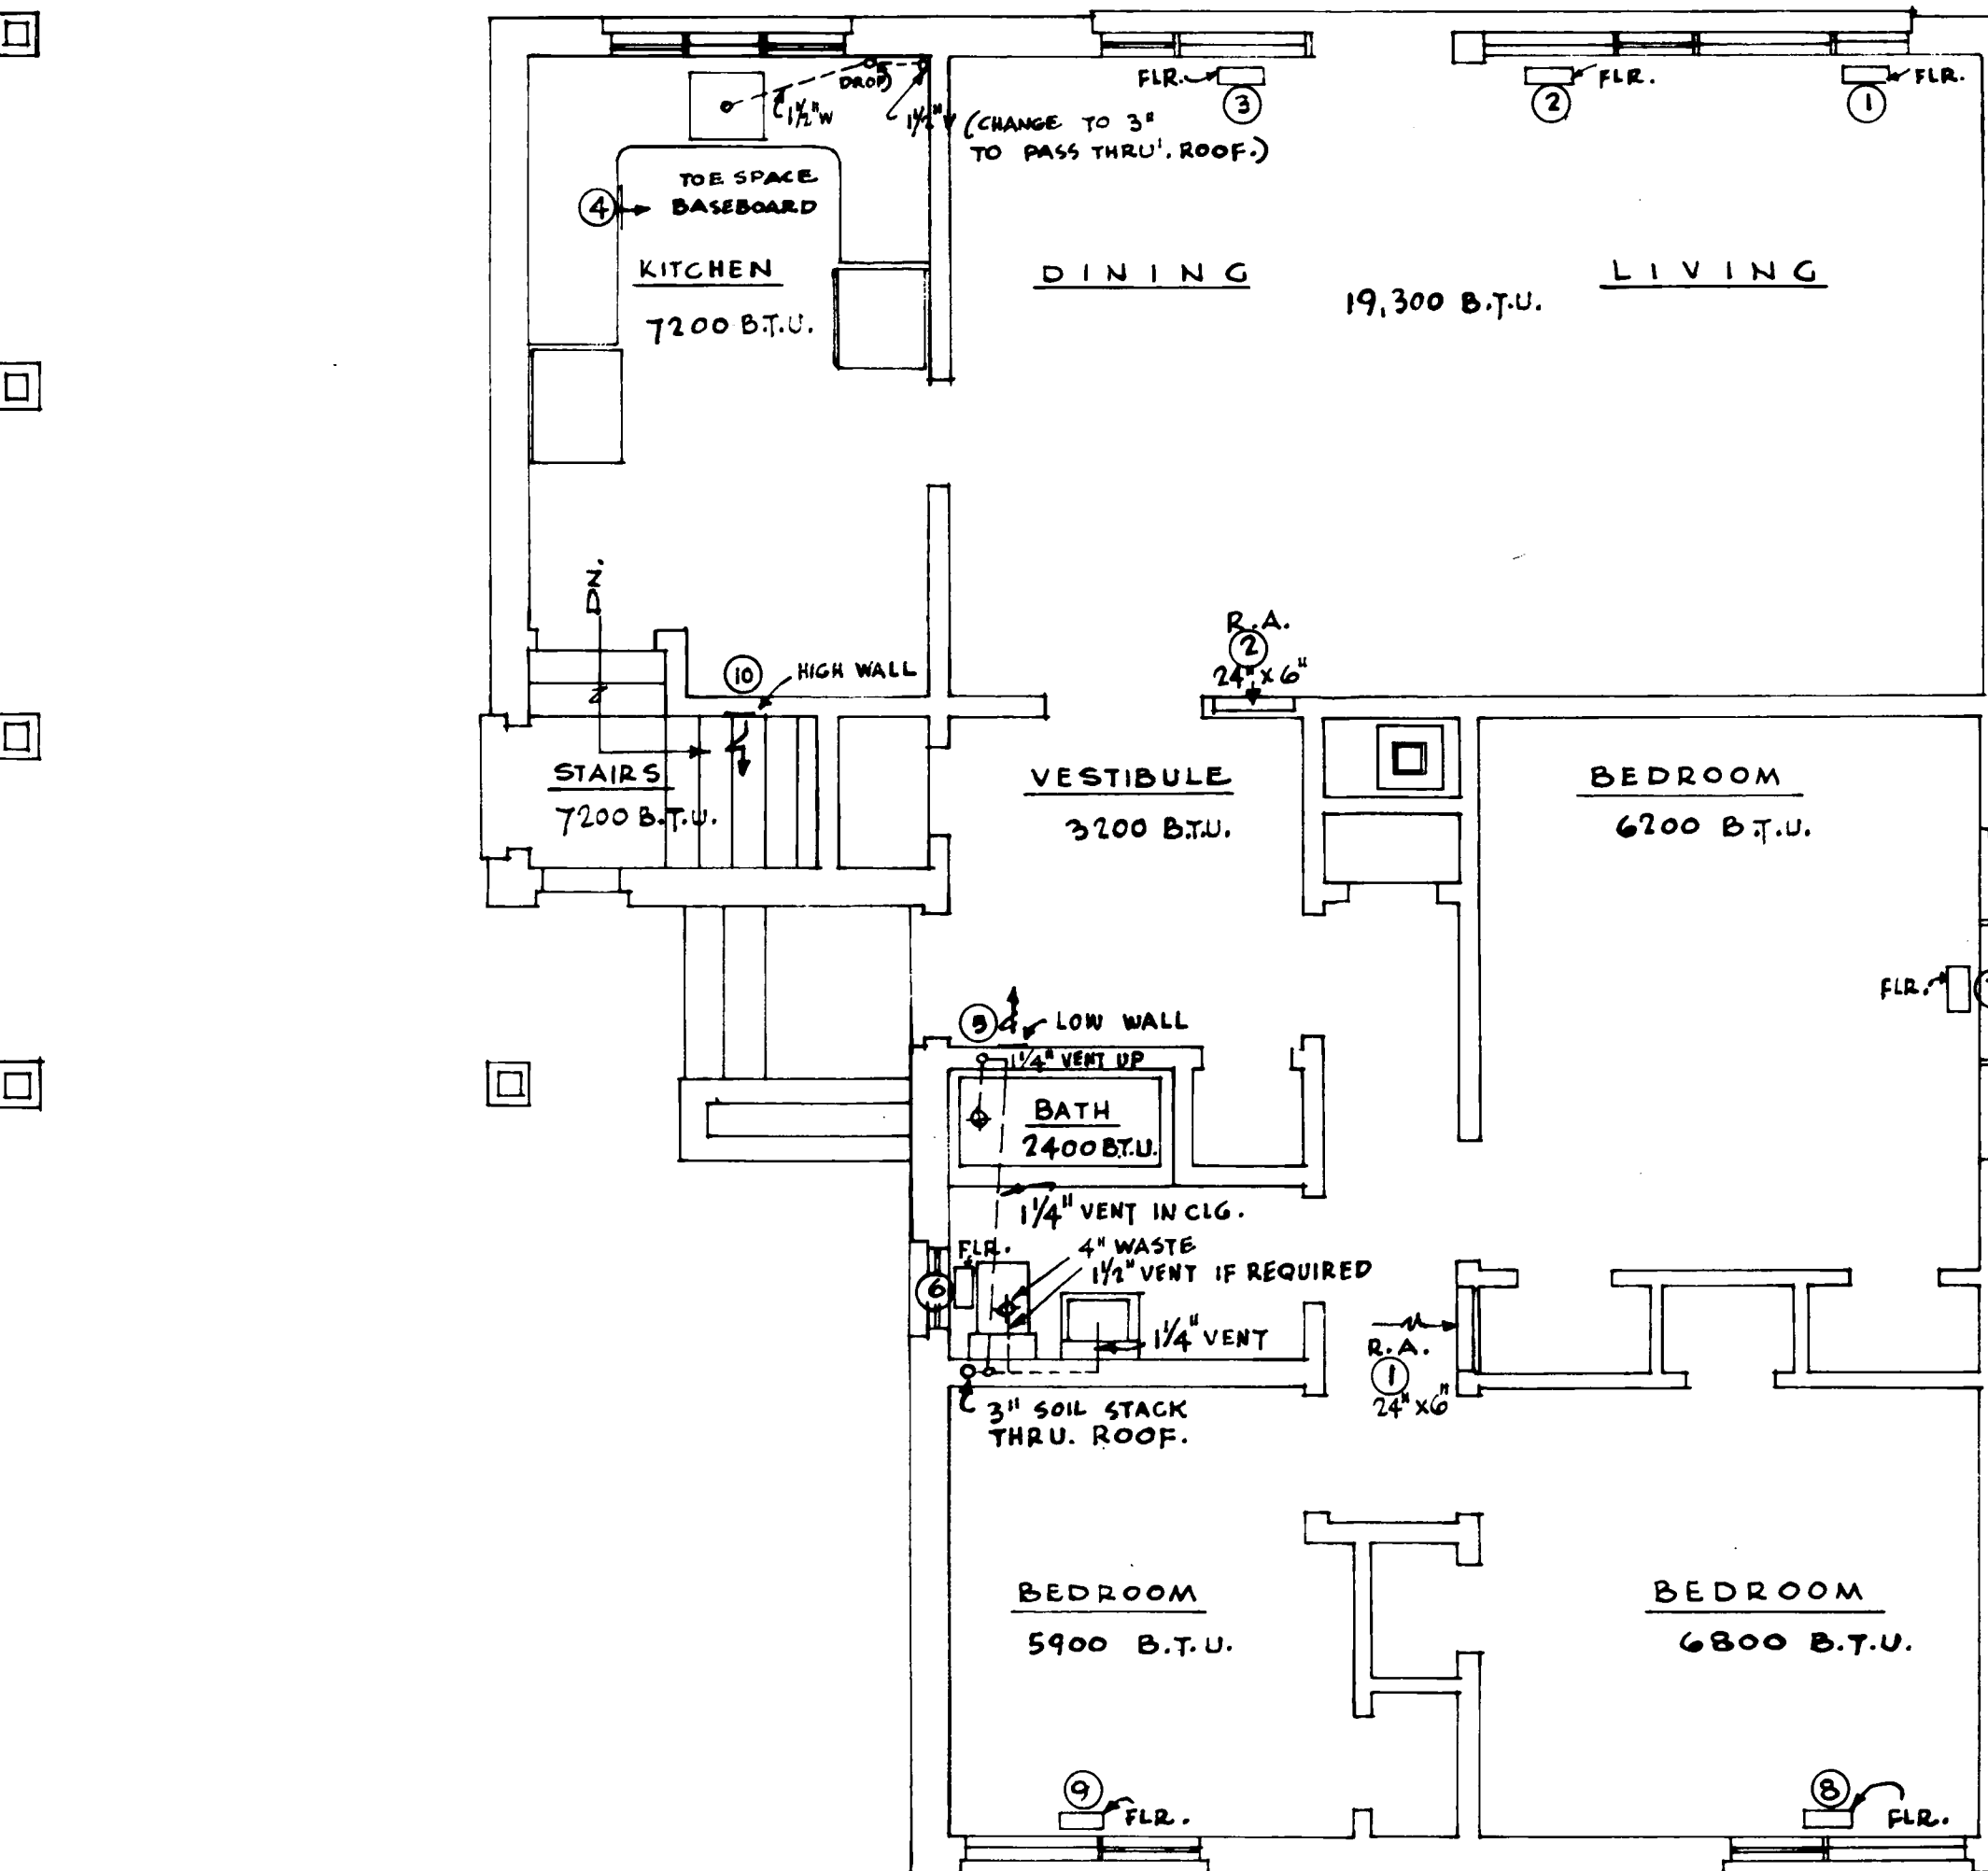

GROUND FLOOR PLAN

NOTES

HEATING

1. THIS HEATING SYSTEM HAS BEEN DESIGNED FOR MINUS 10°F OUTSIDE TEMP. TO 70°F INSIDE TEMP. FOR OTHERS REVISE AS FOLLOWS.— MINUS 20° ADD 15% TO BTU LOSSES AND FURNACE. MINUS 30° ADD 30% TO BTU LOSSES AND FURNACE.

2. PROVIDE 7" ROUND SMOKE PIPE

3. INSTALL DAMPERS IN ALL SUPPLY AND RETURN AIR BRANCHES. INSULATE ALL DUCTWORK IN UNHEATED AREAS.

4. THIS SYSTEM INCLUDING ALL EQUIPMENT OR PARTS WHICH FORM A PART OF THIS SYSTEM, SHALL BE INSTALLED IN STRICT ACCORDANCE WITH ALL LOCAL, PROVINCIAL AND NATIONAL CODES, BY-LAWS OR REGULATIONS WHICH MAY APPLY.

5. ABBREVIATIONS:

H.W. HIGH WALL REGISTER.
L.W. LOW WALL REGISTER.
B.B. BASEBOARD REGISTER.
F.L.R. FLOOR REGISTER.
C.L.G. CEILING REGISTER.
B.J. DUCT BETWEEN JOISTS.
R.A. RETURN AIR SUPPLY.
S.A. WARM AIR SUPPLY.

6. MINIMUM REGISTER SIZES:

6" ROUND BRANCH = WALL & CEILING 10"X6"
FLOOR = 4"X12"
5" ROUND BRANCH = WALL & CEILING 8"X6"
FLOOR = 4"X10"

FOLLOW RECOMMENDATIONS OF THE NATIONAL WARM AIR HEATING AND AIR CONDITIONING ASSOC. OF CANADA.

PLUMBING

1. PROVIDE 1/2" HOT & COLD PIPING TO ALL FIXTURES.

2. FIXTURE CONNECTIONS:

FIXTURE	WATER	WASTE	VENT	COLD	HOT
WATER CLOSET	1 1/2"	1 1/2"	1 1/2"	1 1/2"	1 1/2"
LAVATORY	1 1/4"	1 1/4"	3/8"	3/8"	3/8"
SINK OR LAUNDRY TUB	1 1/2"	1 1/4"	1/2"	1/2"	1/2"

3. ABBREVIATIONS

S.W. STOP & WASTE COCK.
V. VENT.
W. WASTE.
C.O. CLEANOUT.

4. PLUMBING SYSTEM MUST BE INSTALLED IN ACCORDANCE WITH ALL NATIONAL, PROVINCIAL OR LOCAL CODES IN EFFECT.

3/12/58 V. Kozlov DATE NHA STDS CHKD BY DATE REVISIONS BY ARCHITECT	
	EARL R. DUNLOP DATE 4 DEC. 1958 DESIGN NO. SHEET NO. 299 4 of 4
	CENTRAL MORTGAGE AND HOUSING CORPORATION